


GROUND FLOOR PLAN

NOTE :-
 1. CONTRACTOR TO CHECK AND VERIFY ALL DIMENSIONS BEFORE EXECUTION OF THE WORK.
 2. FIGURED DIMENSIONS SHALL BE FOLLOWED.
 3. ALL DIMENSIONS GIVEN ARE IN MILLIMETERS UNLESS OTHERWISE SPECIFIED.

SCHEDULE OF JOINERY				
S.NO	ITEM	TYPE	SIZE	ROLLING SHUTTER S 1800 X 2100
1	DOOR	MD	2400 X 2600	1 WINDOW 1 W1 1800 X 1800
2	DOOR 1	DD	1500 X 2600	2 WINDOW 2 W2 1200 X 1800
3	DOOR 2	DD1	1200 X 2600	3 WINDOW 3 W3 900 X 1800
4	DOOR 3	D1	1000 X 2600	VENTILATOR
5	DOOR 4	D2	800 X 2600	1 VENTILATOR V 600 X 500

SCALE: NTS
 DATE: JAN 2017
 DRAWN: ASP
 CHECKED: VRNK

CLINT :- ANDHRA PRADESH MEDICAL SERVICES AND INFRASTRUCTURE DEVELOPMENT CORPORATION
 PROJECT :- MATERNITY & CHILD HEALTH BLOCK IN GOVT GENERAL HOSPITAL COMPLEX AT KAKINADA.

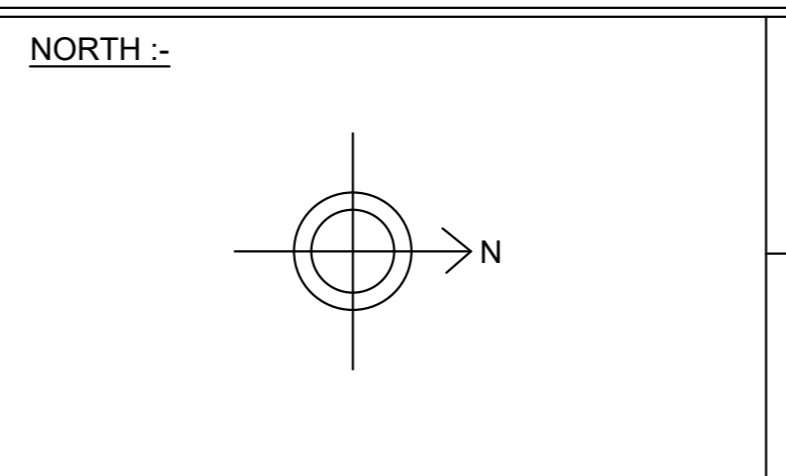

DRAWING TITLE :- GROUND FLOOR PLAN (BUILT UP AREA :- 3196.75 SQ M)
 DRAWING NUMBER :- SK - MCHK - WD - A01